 



DATE PLOTTED = 11/20/2025 3:11:56 PM
PEN TABLE = R:\Proj\0021497\01\0021497.dgn
PLOT CONFIG = CG-PDF.plt
MODEL SHEET NAMES
FILE NAME: R:\Proj\0021497\01\CADD\SiteProposedPlan\0021497.dgn

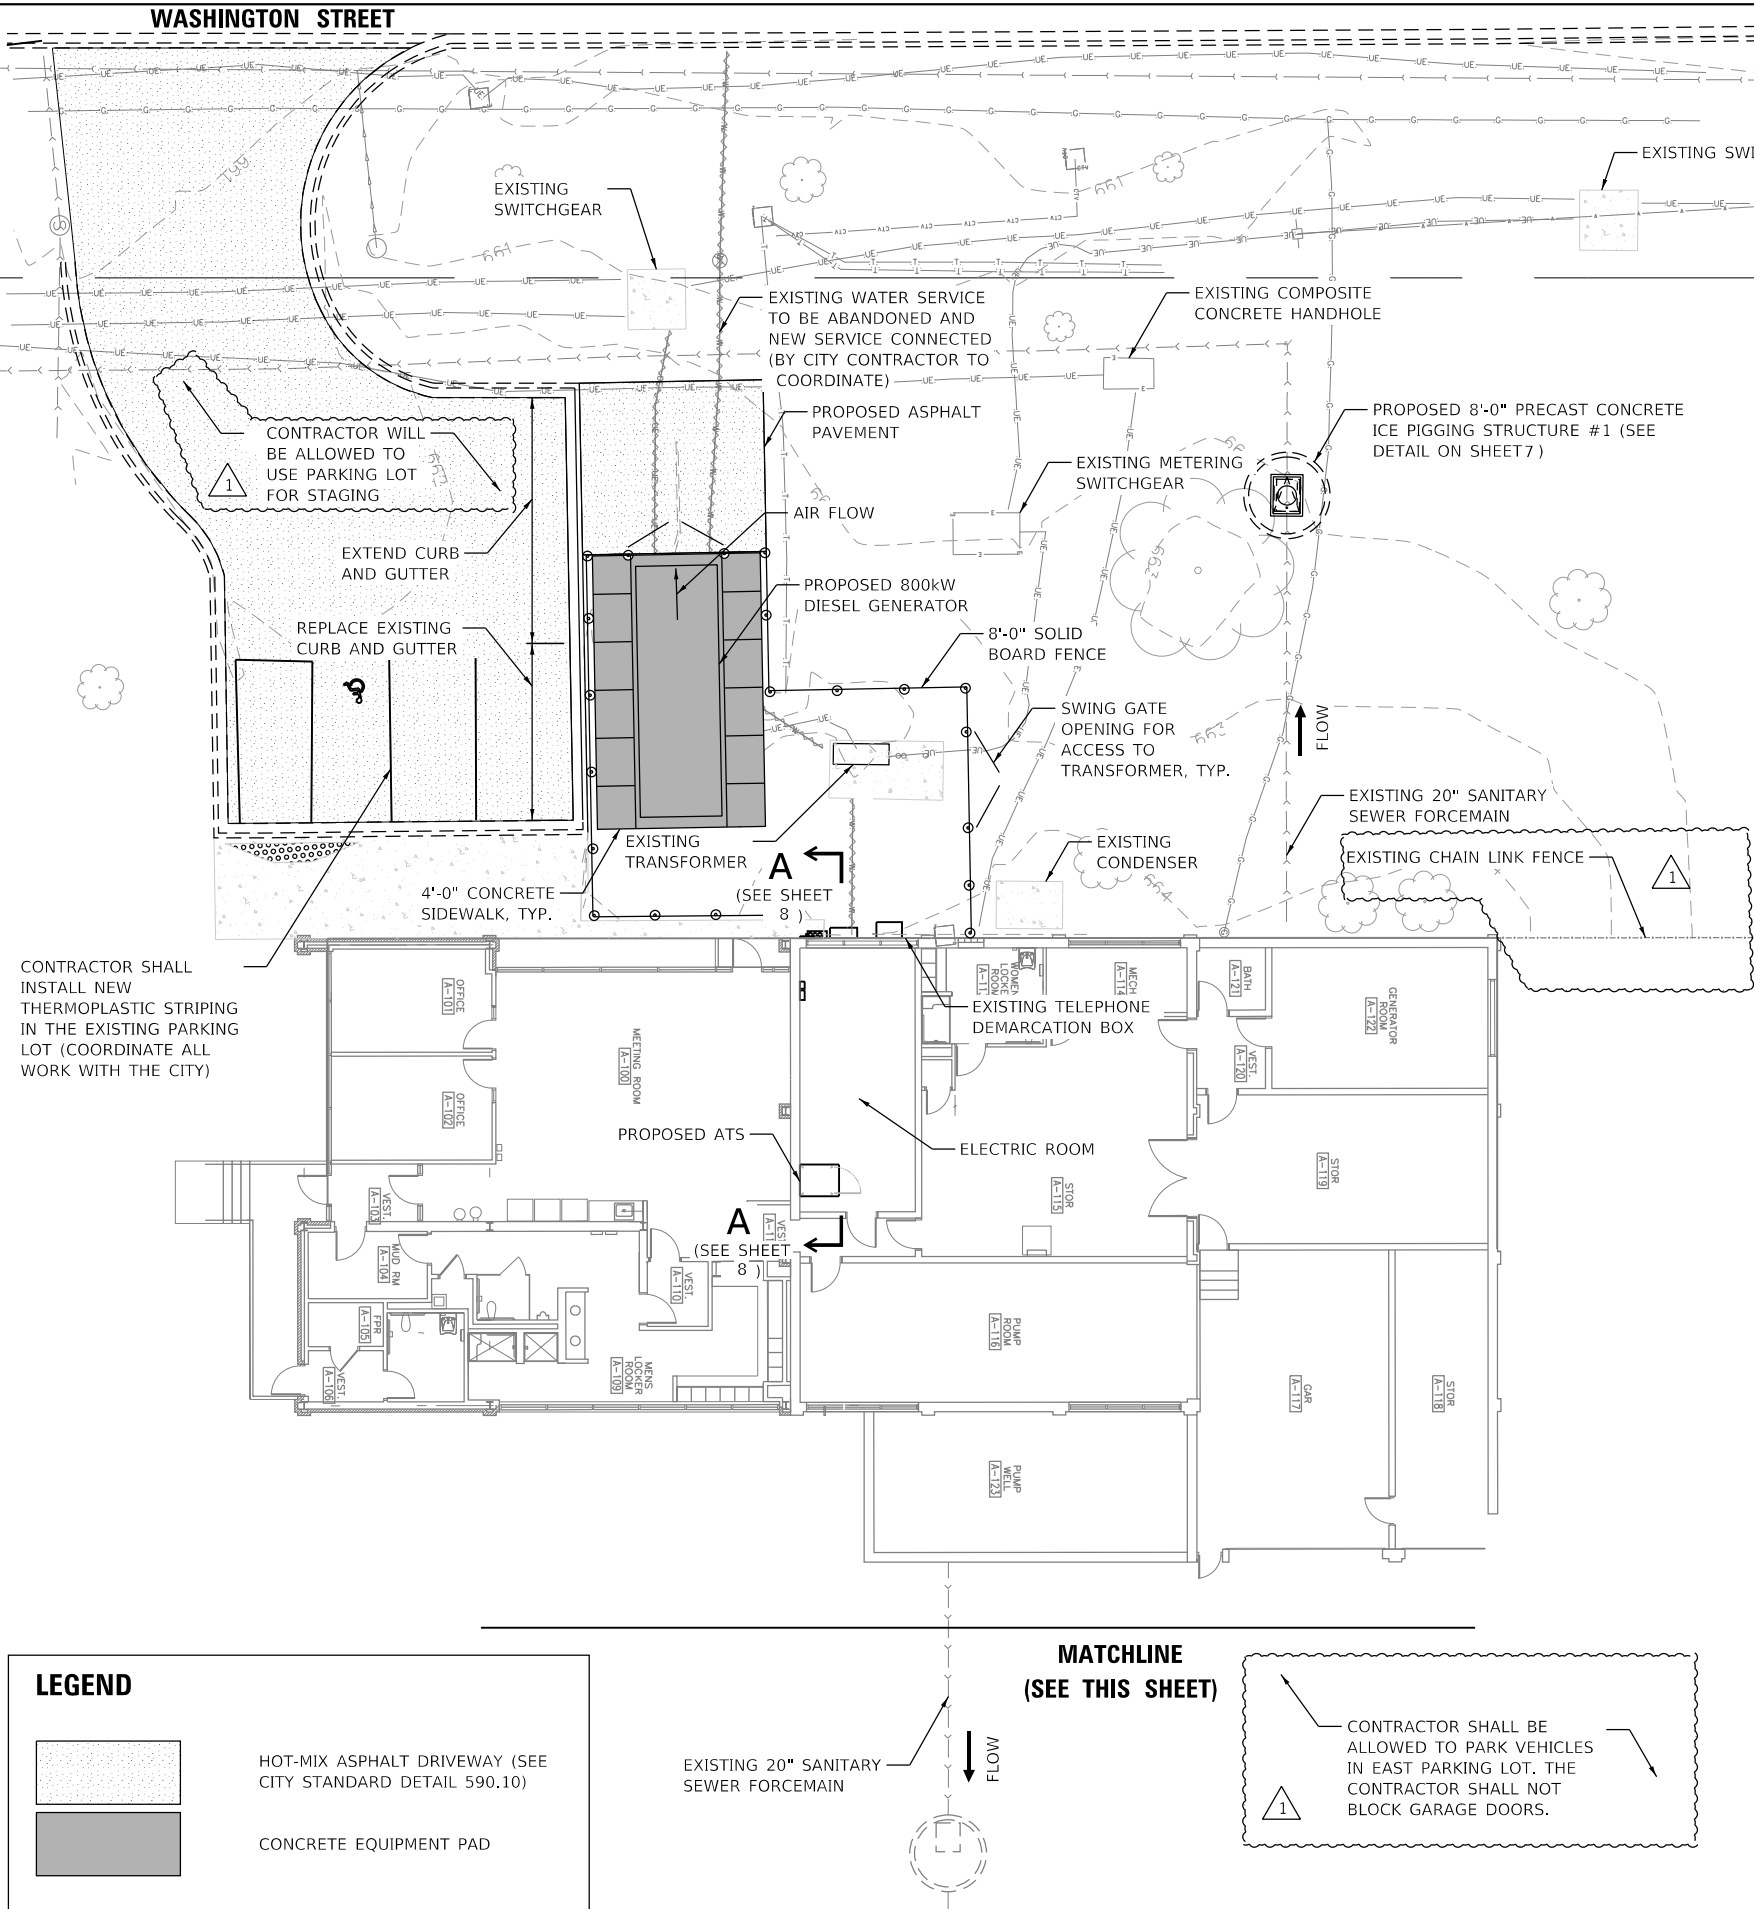

EX ROW

PUMP WELL
A-123

**MATCHLINE
(SEE THIS SHEET)**

PROPOSED 8'-0" PRECAST CONCRETE ICE PIGGING STRUCTURE #2 (SEE DETAIL ON SHEET 7)

ALUMINUM ACCESS HATCH WITH H2O RATING

40"x26" CLEAR OPENING (BILCO J-ALH20 OR EQUAL)

HEAVY DUTY VALVE BOX (TYLER UNION OR EQUAL)

EXISTING 20" SANITARY SEWER FORCEMAIN



USER NAME = WaterResources	DESIGNED - KL	REVISED - PER VILLAGE COMMENTS
DRAWN - AF	REVISED -	
PLOT SCALE = 20.0000' / in.	CHECKED - KL	REVISED -
PLOT DATE = 11/20/2025	DATE -	REVISED -



CITY OF NAPERVILLE
400 S. EAGLE STREET
NAPERVILLE IL, 60540

PROPOSED SITE PLAN				RTE.	SECTION	COUNTY	TOTAL SHEETS	SHEET NO.
							26	6
				CONTRACT NO.				
SCALE: 1" = 10'				ILLINOIS FED. AID PROJECT				