 



DATE PLOTTED = 11/20/2025 3:11:56 PM
PEN TABLE = R:\Proj\0021497\01\0021497.dgn
PLOT CONFIG = CG-HPDF.plt
MODEL SHEET NAMES
FILE NAME: R:\Proj\0021497\01\CADD\SiteProposedPlan\0021497.dgn

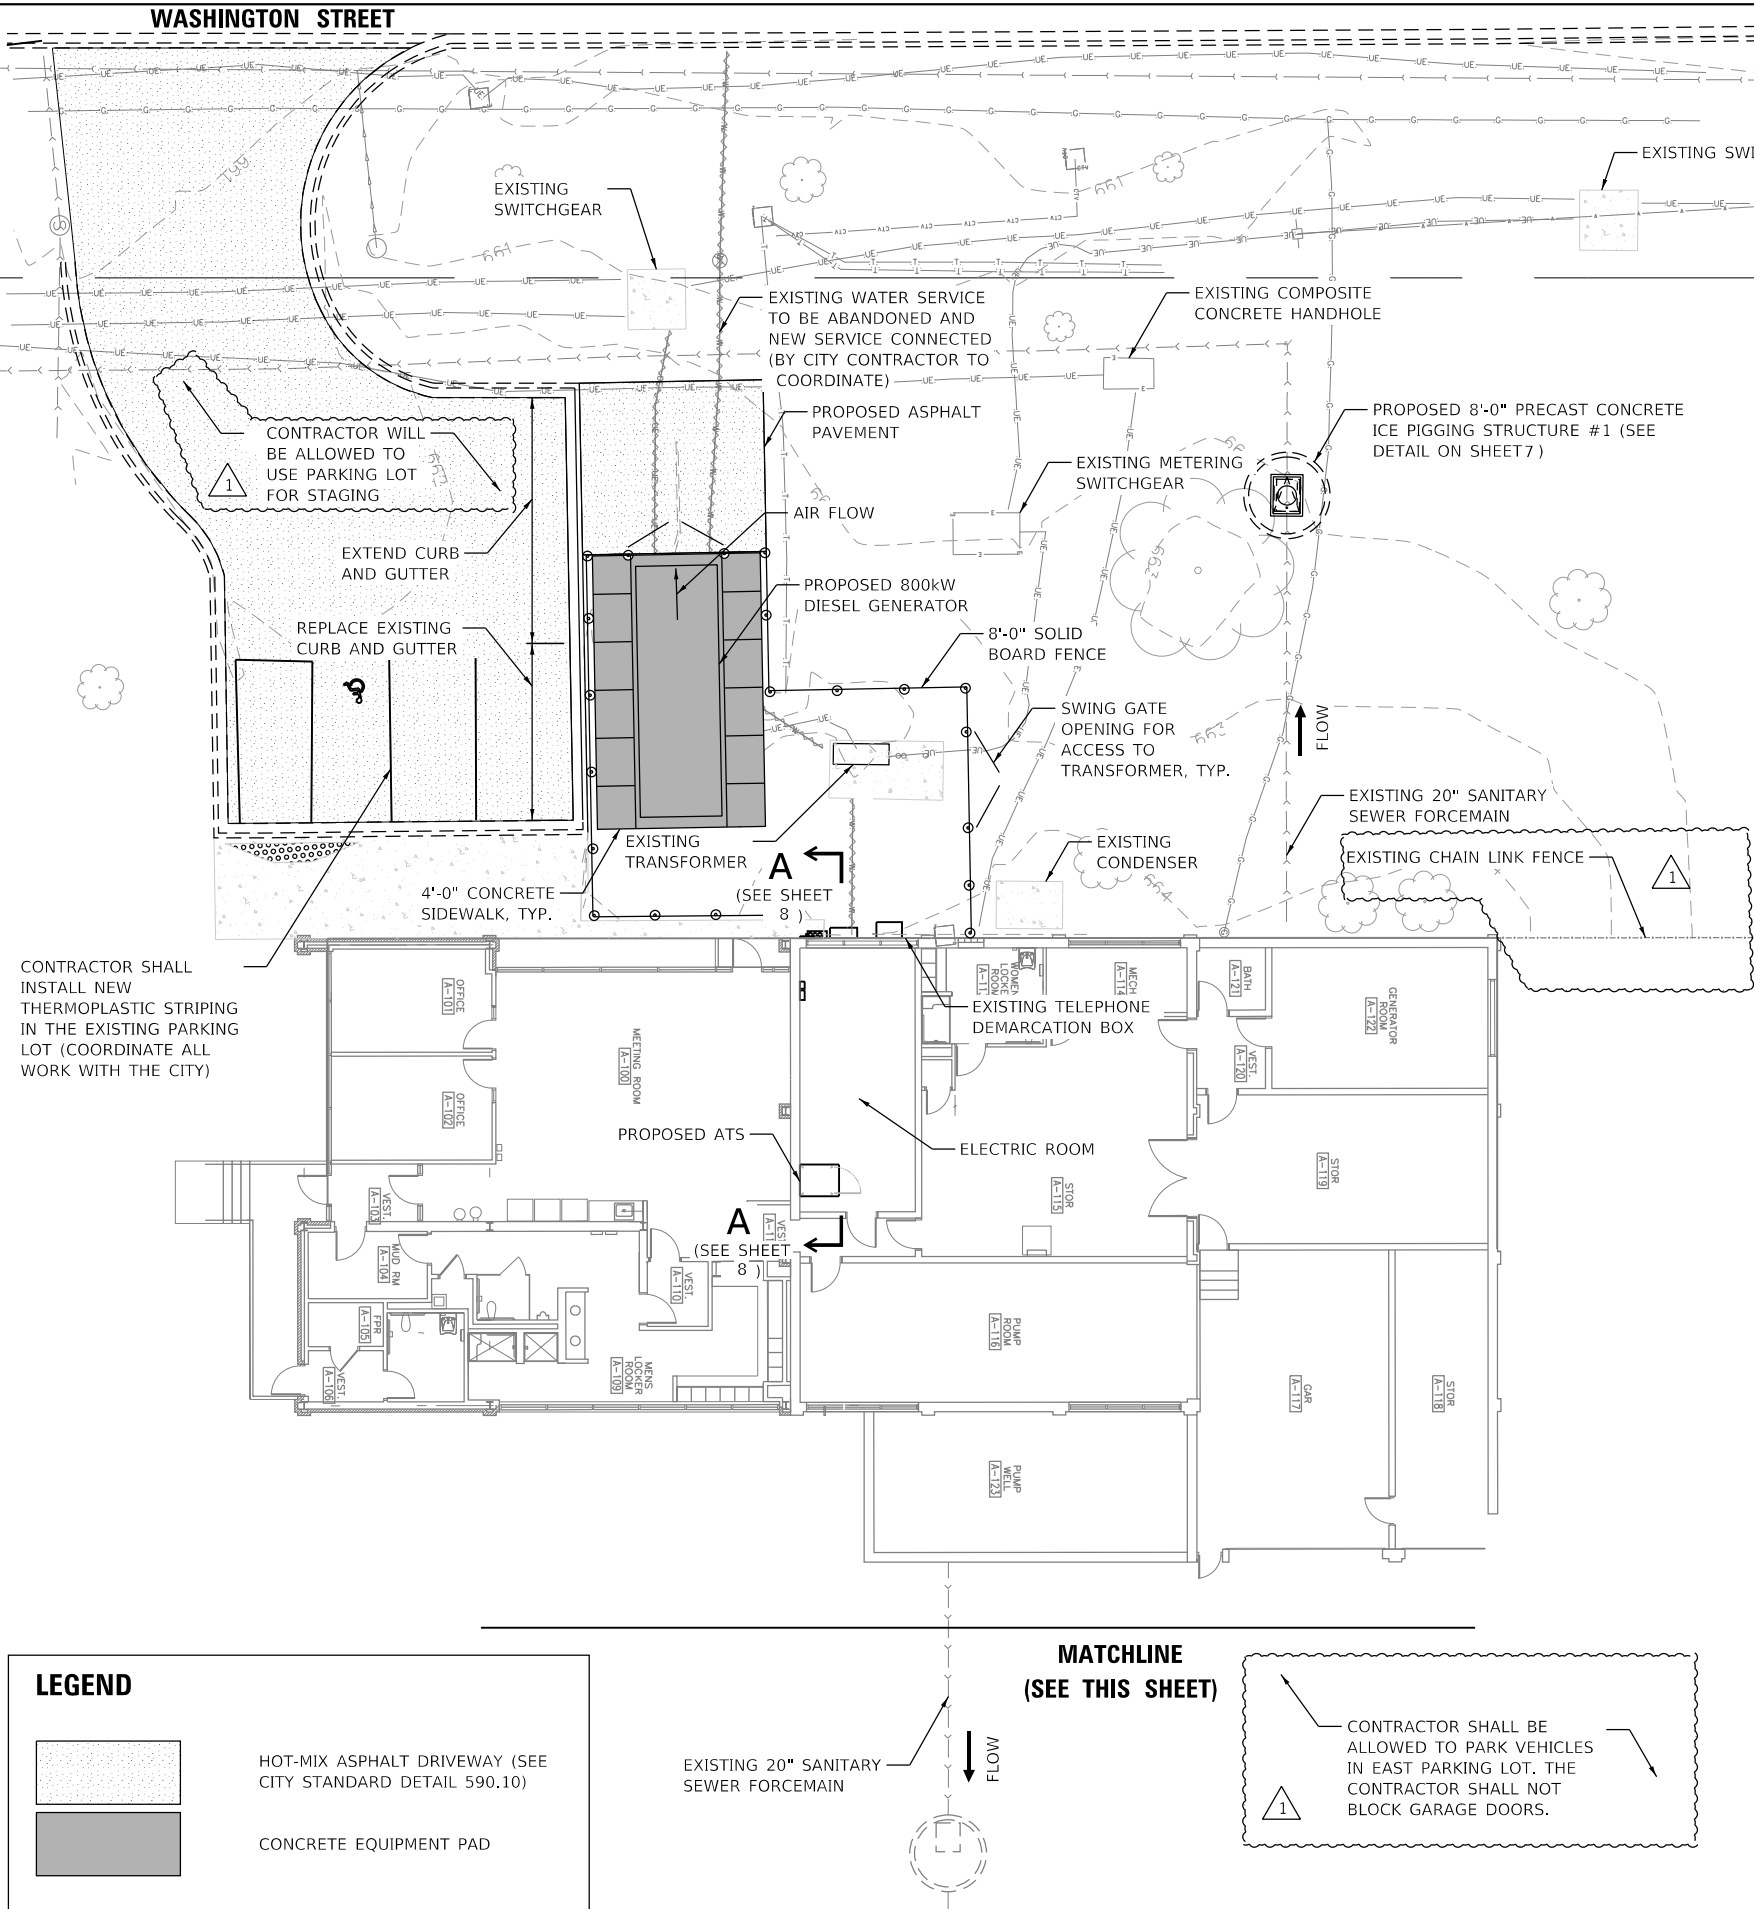

EX ROW

PUMP WELL
A-123

MATCHLINE
(SEE THIS SHEET)

LEGEND



HOT-MIX ASPHALT DRIVEWAY (SEE CITY STANDARD DETAIL 590.10)

CONCRETE EQUIPMENT PAD

MATCHLINE
(SEE THIS SHEET)

PROPOSED SITE PLAN		RTE.	SECTION	COUNTY	TOTAL SHEETS	SHEET NO.
SCALE: 1" = 10'					26	6
SHEET OF SHEETS		CONTRACT NO.				
STA. TO STA.		ILLINOIS FED. AID PROJECT				



USER NAME = WaterResources	DESIGNED - KL	REVISED - PER VILLAGE COMMENTS
DRAWN - AF	REVIS	
PLOT SCALE = 20.0000' / in.	CHECKED - KL	REVIS
PLOT DATE = 11/20/2025	DATE -	REVIS



CITY OF NAPERVILLE
400 S. EAGLE STREET
NAPERVILLE IL, 60540

EXHIBIT D