



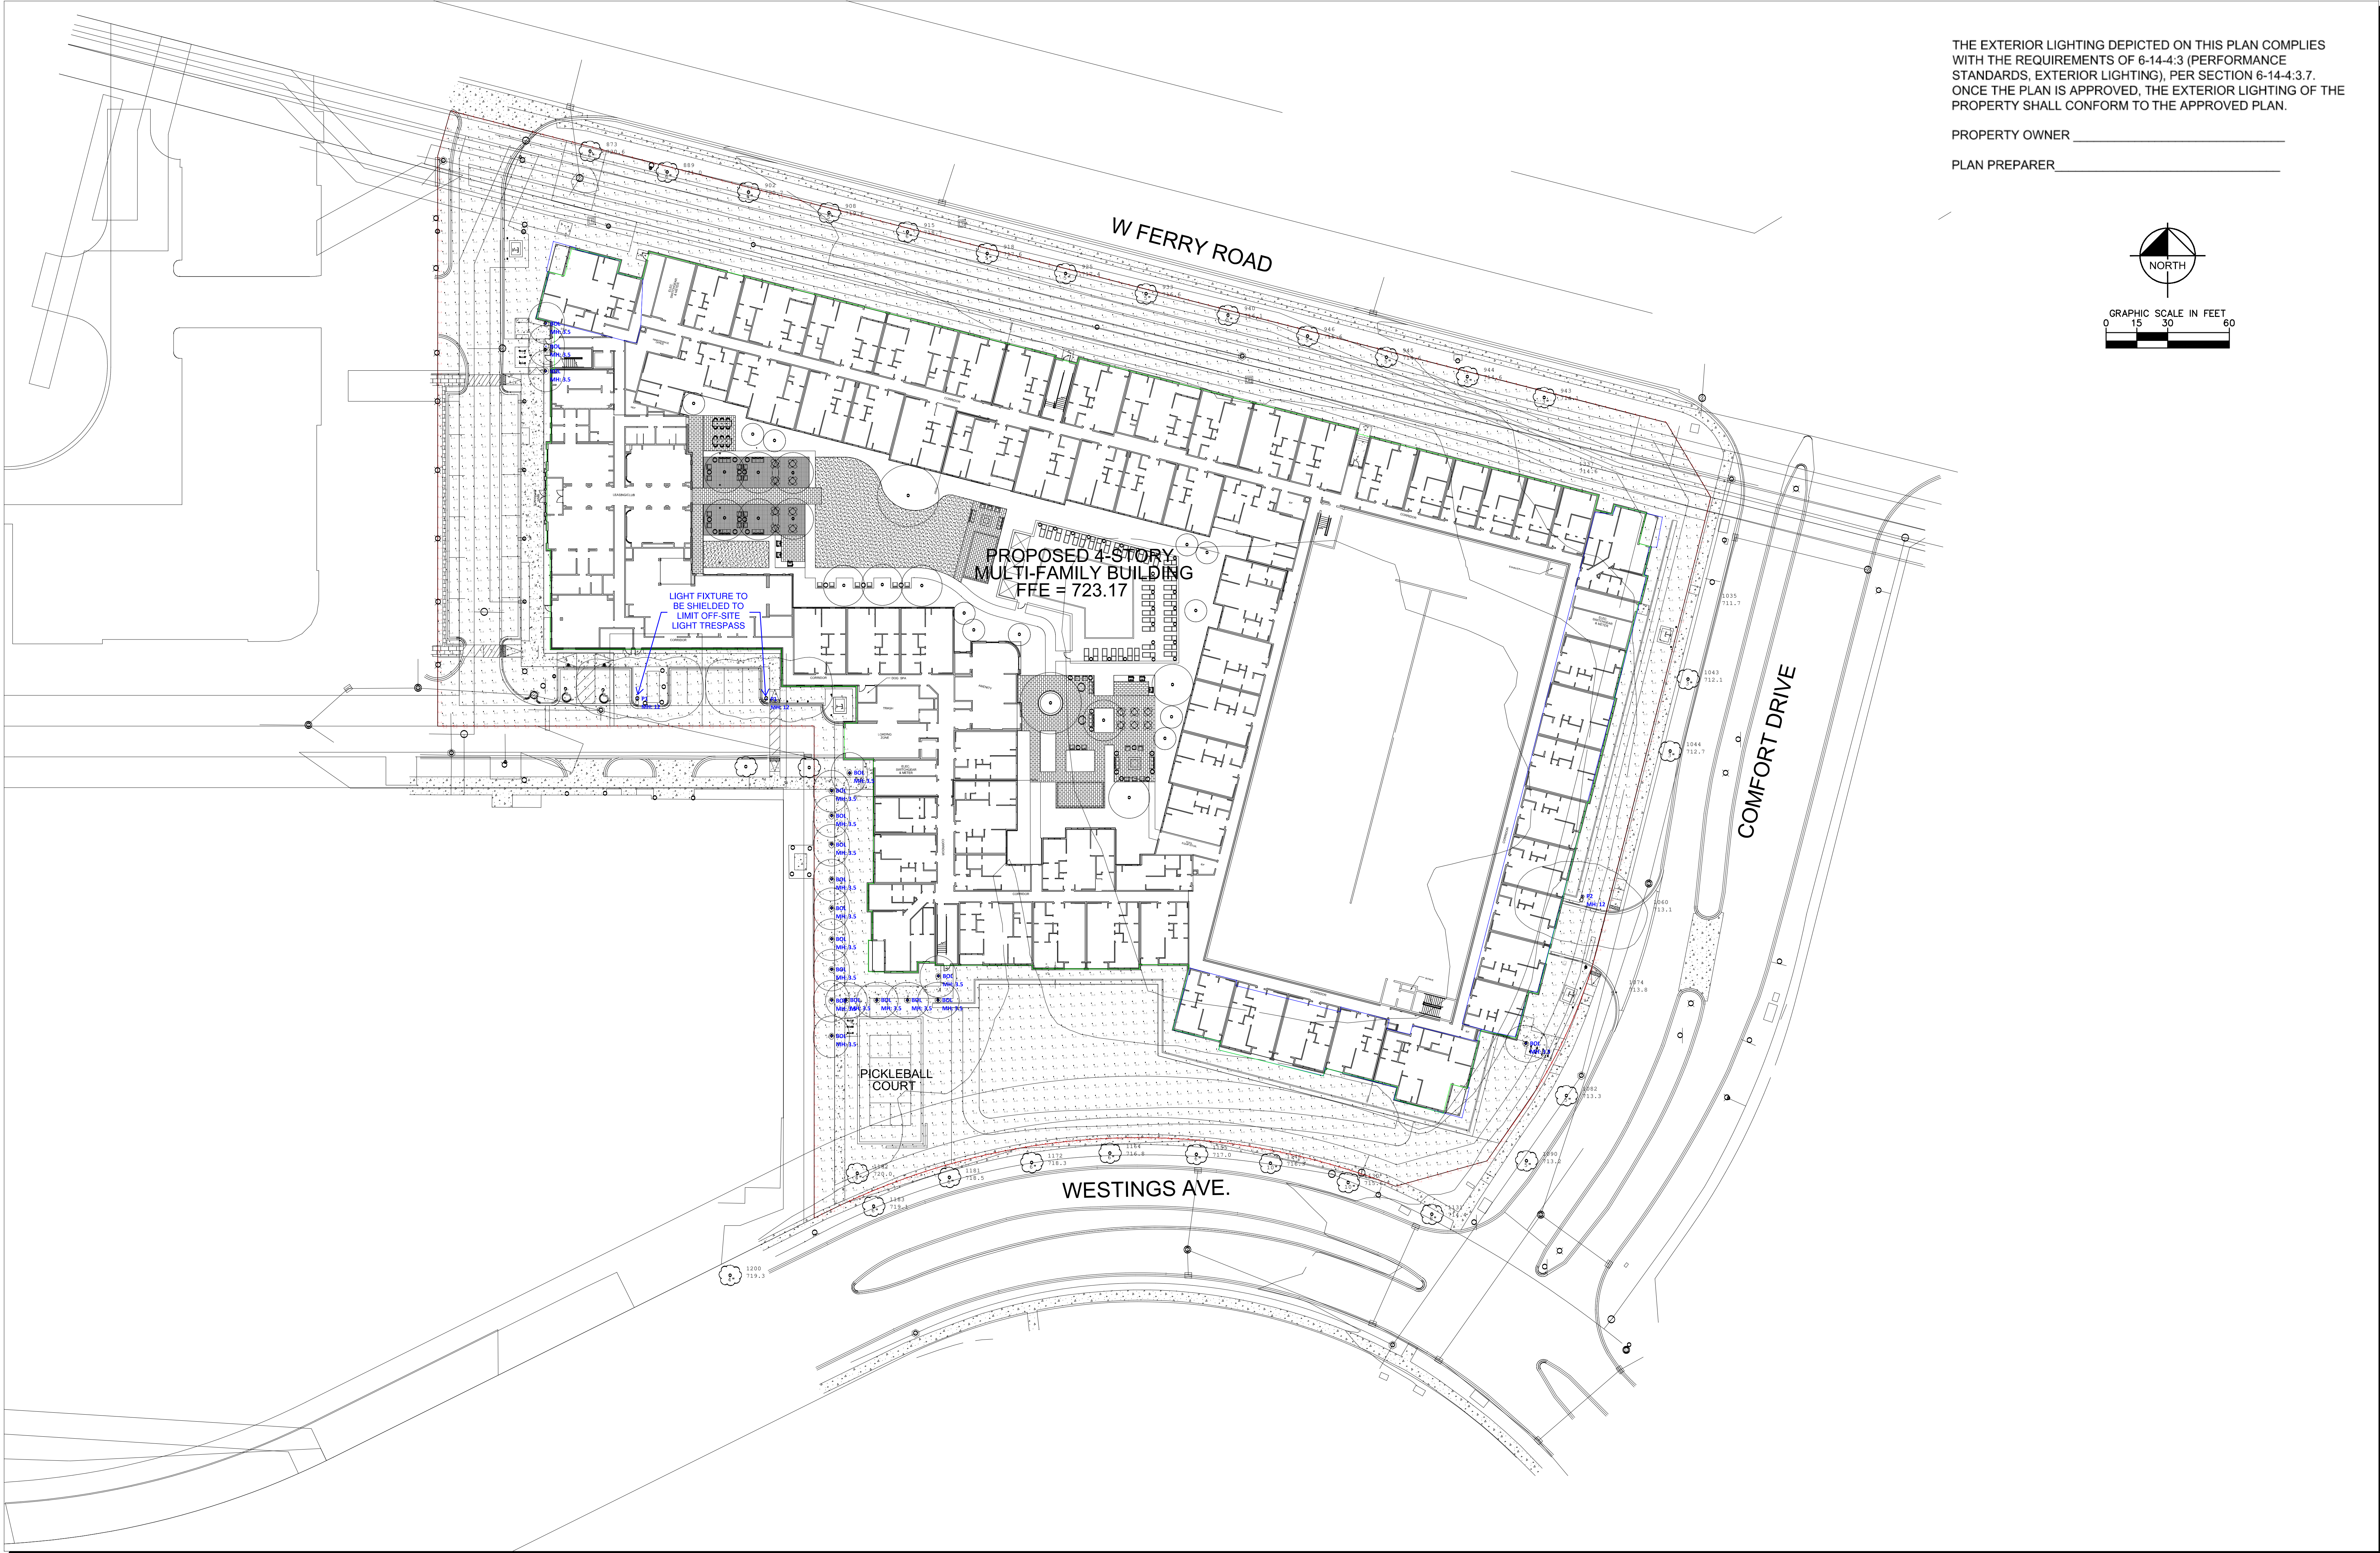

THE EXTERIOR LIGHTING DEPICTED ON THIS PLAN COMPLIES WITH THE REQUIREMENTS OF 6-14-4:3 (PERFORMANCE STANDARDS, EXTERIOR LIGHTING), PER SECTION 6-14-4:3.7. ONCE THE PLAN IS APPROVED, THE EXTERIOR LIGHTING OF THE PROPERTY SHALL CONFORM TO THE APPROVED PLAN.

PROPERTY OWNER _____

PLAN PREPARER _____

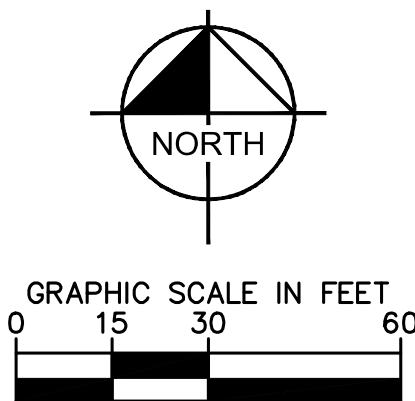

Luminaire Schedule					
Symbol	Tag	Qty	[MANUFAC]	Description	LLF
	P1	2	Spitzer Lighting	100L 80W PTM T2 FR HSS 80CRI 40K	0.750
	P2	1	Spitzer	100L 80W PTM T3 SOLITE GLASS 40K	0.750
	BOL	19	Spitzer	BRA 24LC 2000LM 4000K T5	0.750

Calculation Summary							
Label	CalcType	Units	Avg	Max	Min	Avg/Min	Max/Min
Property Line	Illuminance	Fc	0.09	4.0	0.0	N.A.	N.A.
Revised							
Site Lighting	Illuminance	Fc	0.50	20.8	0.0	N.A.	N.A.

- Notes :
- 1. Calculation Work Plane : Ground Level
 - 2. Fixture Mounting Height : Noted Above
 - 3. Calculation Point Spacing : 5' x 5'

City Gate North Photometric Plan

Drawn By: Jesse Vaniseghem

Date:7/30/2026

Notes :