



ARCHITECTURE
LAND PLANNING
INTERIOR ARCHITECTURE
LANDSCAPE ARCHITECTURE

RWE MANAGEMENT COMPANY
18 W 301 E Frontage Rd., Suite 106
Naperville, IL 60563
(630) 724-0883
ADMIN@RWE.COM

Naperville Area Humane Society
A Humane Society of America Partner
1620 W. Diehl Road
Naperville, IL 60563

DATE: 07-19-2019
DRAWN: M.M.
CHECKED: M.M.
DATE: 08-05-2019


2019-0025
PROJECT NUMBER

FILE NUMBER: 07-19-2019
DATE: 07-19-2019
BY: M.M.
CHECKED BY: M.M.
SCALE: AS SHOWN

copyright - LINEN GROUP INC.
ALL RIGHTS RESERVED.
NO PART OF THIS DRAWING IS TO BE REPRODUCED OR TRANSMITTED IN ANY FORM OR BY ANY MEANS, ELECTRONIC OR MECHANICAL, INCLUDING PHOTOCOPYING, RECORDING, OR BY ANY INFORMATION STORAGE AND RETRIEVAL SYSTEM, WITHOUT THE WRITTEN PERMISSION OF LINEN GROUP INC.


PHOTOMETRIC SITE PLAN

BEST NAME: A-0.2
DATE: 11/20/2020

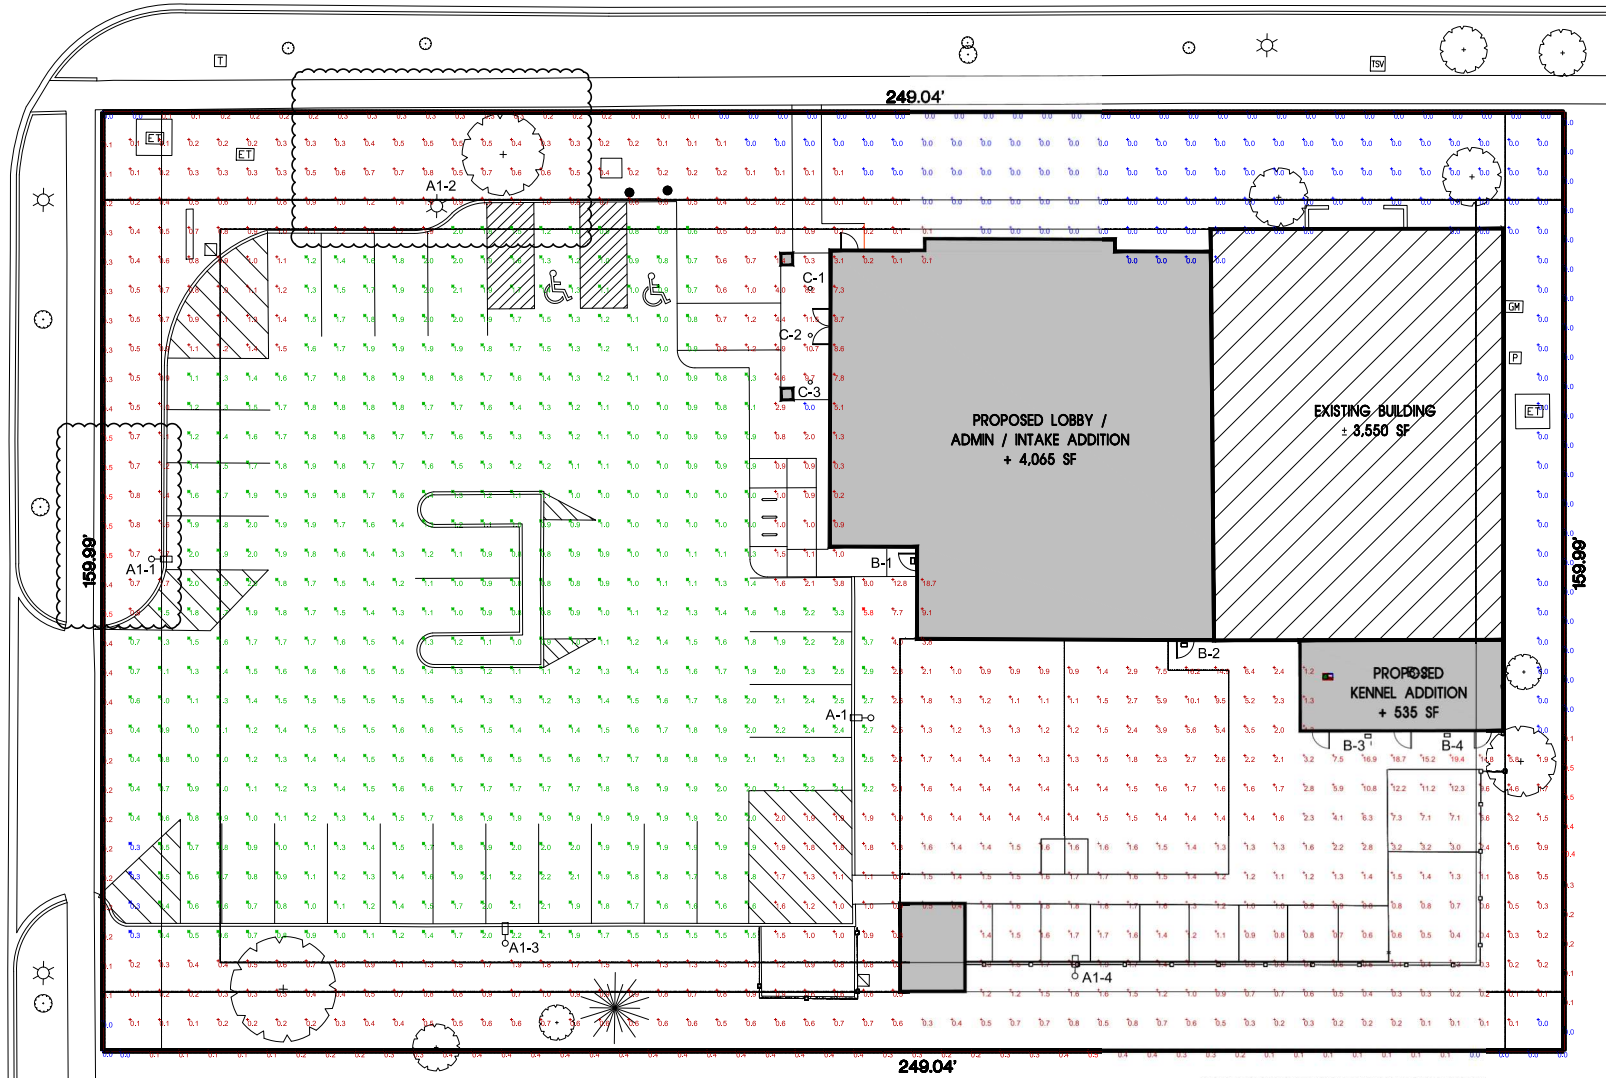

Symbol	Label	Quantity	Manufacturer	Eq. # / Qty	Description	Lamp	Number	Notes	Lumen Per Foot	Light Loss Factor	Footcandle
□	A	1	Alibaba Lighting	60W LED F20 40K T8M SVOLVT	60W LED F20 40K T8M SVOLVT	LED	1	60W LED F20 40K T8M SVOLVT	6700	0.85	70
□	A1	4	Alibaba Lighting	60W LED F20 40K T8M SVOLVT	60W LED F20 40K T8M SVOLVT with translucent shade	LED	1	60W LED F20 40K T8M SVOLVT with translucent shade	6700	0.85	70
□	B	4	Alibaba Lighting	POST LED F20 40K T8M SVOLVT	POST LED Performance Package 2 60W, 4000K, 100LM, 80CRI, CLEAR, SEMI-RETRACTABLE REFLECTOR SVOLVT	LED	1	POST LED Performance Package 2 60W, 4000K, 100LM, 80CRI, CLEAR, SEMI-RETRACTABLE REFLECTOR SVOLVT	1000	0.85	15
○	C	1	Alibaba Lighting	LINE 40W LED A40S L85	LINE 40W LED A40S L85	LED	1	LINE 40W LED A40S L85	1000	0.85	12.5

Location	Latitude	Longitude	Altitude	Orientation	Height	Footcandle
1. A	41.8529	-87.9200	220.00	270.00	2.00	0.00
2. A	41.8529	-87.9200	220.00	270.00	2.00	0.00
3. A	41.8529	-87.9200	220.00	270.00	2.00	0.00
4. A	41.8529	-87.9200	220.00	270.00	2.00	0.00
5. A	41.8529	-87.9200	220.00	270.00	2.00	0.00
6. A	41.8529	-87.9200	220.00	270.00	2.00	0.00
7. A	41.8529	-87.9200	220.00	270.00	2.00	0.00
8. A	41.8529	-87.9200	220.00	270.00	2.00	0.00
9. A	41.8529	-87.9200	220.00	270.00	2.00	0.00
10. A	41.8529	-87.9200	220.00	270.00	2.00	0.00

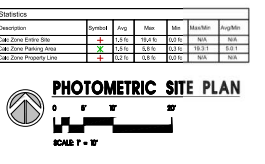

VERIFY THAT THESE DRAWINGS WERE PREPARED BY AQA LIGHTING UNDER MY DIRECT SUPERVISION AND TO THE BEST OF MY PROFESSIONAL KNOWLEDGE THEY CONFORM AND COMPLY TO THE CITY OF NAPERVILLE ZONING CODE.

CITY OF NAPERVILLE, ILLINOIS

Michael Matyas
MICHAEL MATYAS
Professional Design Firm: 184-000209
Expiration Date: 4/26/21

11/20/2020

© COPYRIGHT LINEN GROUP INC.

DATE PLOTTED: 11/20/2020 10:58 AM
PLOTTER: HP DesignJet T1100E
PLOT SCALE: 1:1
PLOT SHEET: A-0.2