


Drawing name: K:\CH\DEV\268581000\_MRV-TacoBell\_Naperville\_IL\2 Design\CAD\PlanSheets\C3.0 - SITE PLAN.dwg C3.0 Apr 15, 2024 8:27pm by Jorden, tested  
 This document, together with the concepts and designs presented herein, is intended only for the specific purpose and client for which it was prepared. Reuse of and improper reliance on this document without written authorization and adaptation by Kimley-Horn and Associates, Inc. shall be without liability to Kimley-Horn and Associates, Inc.

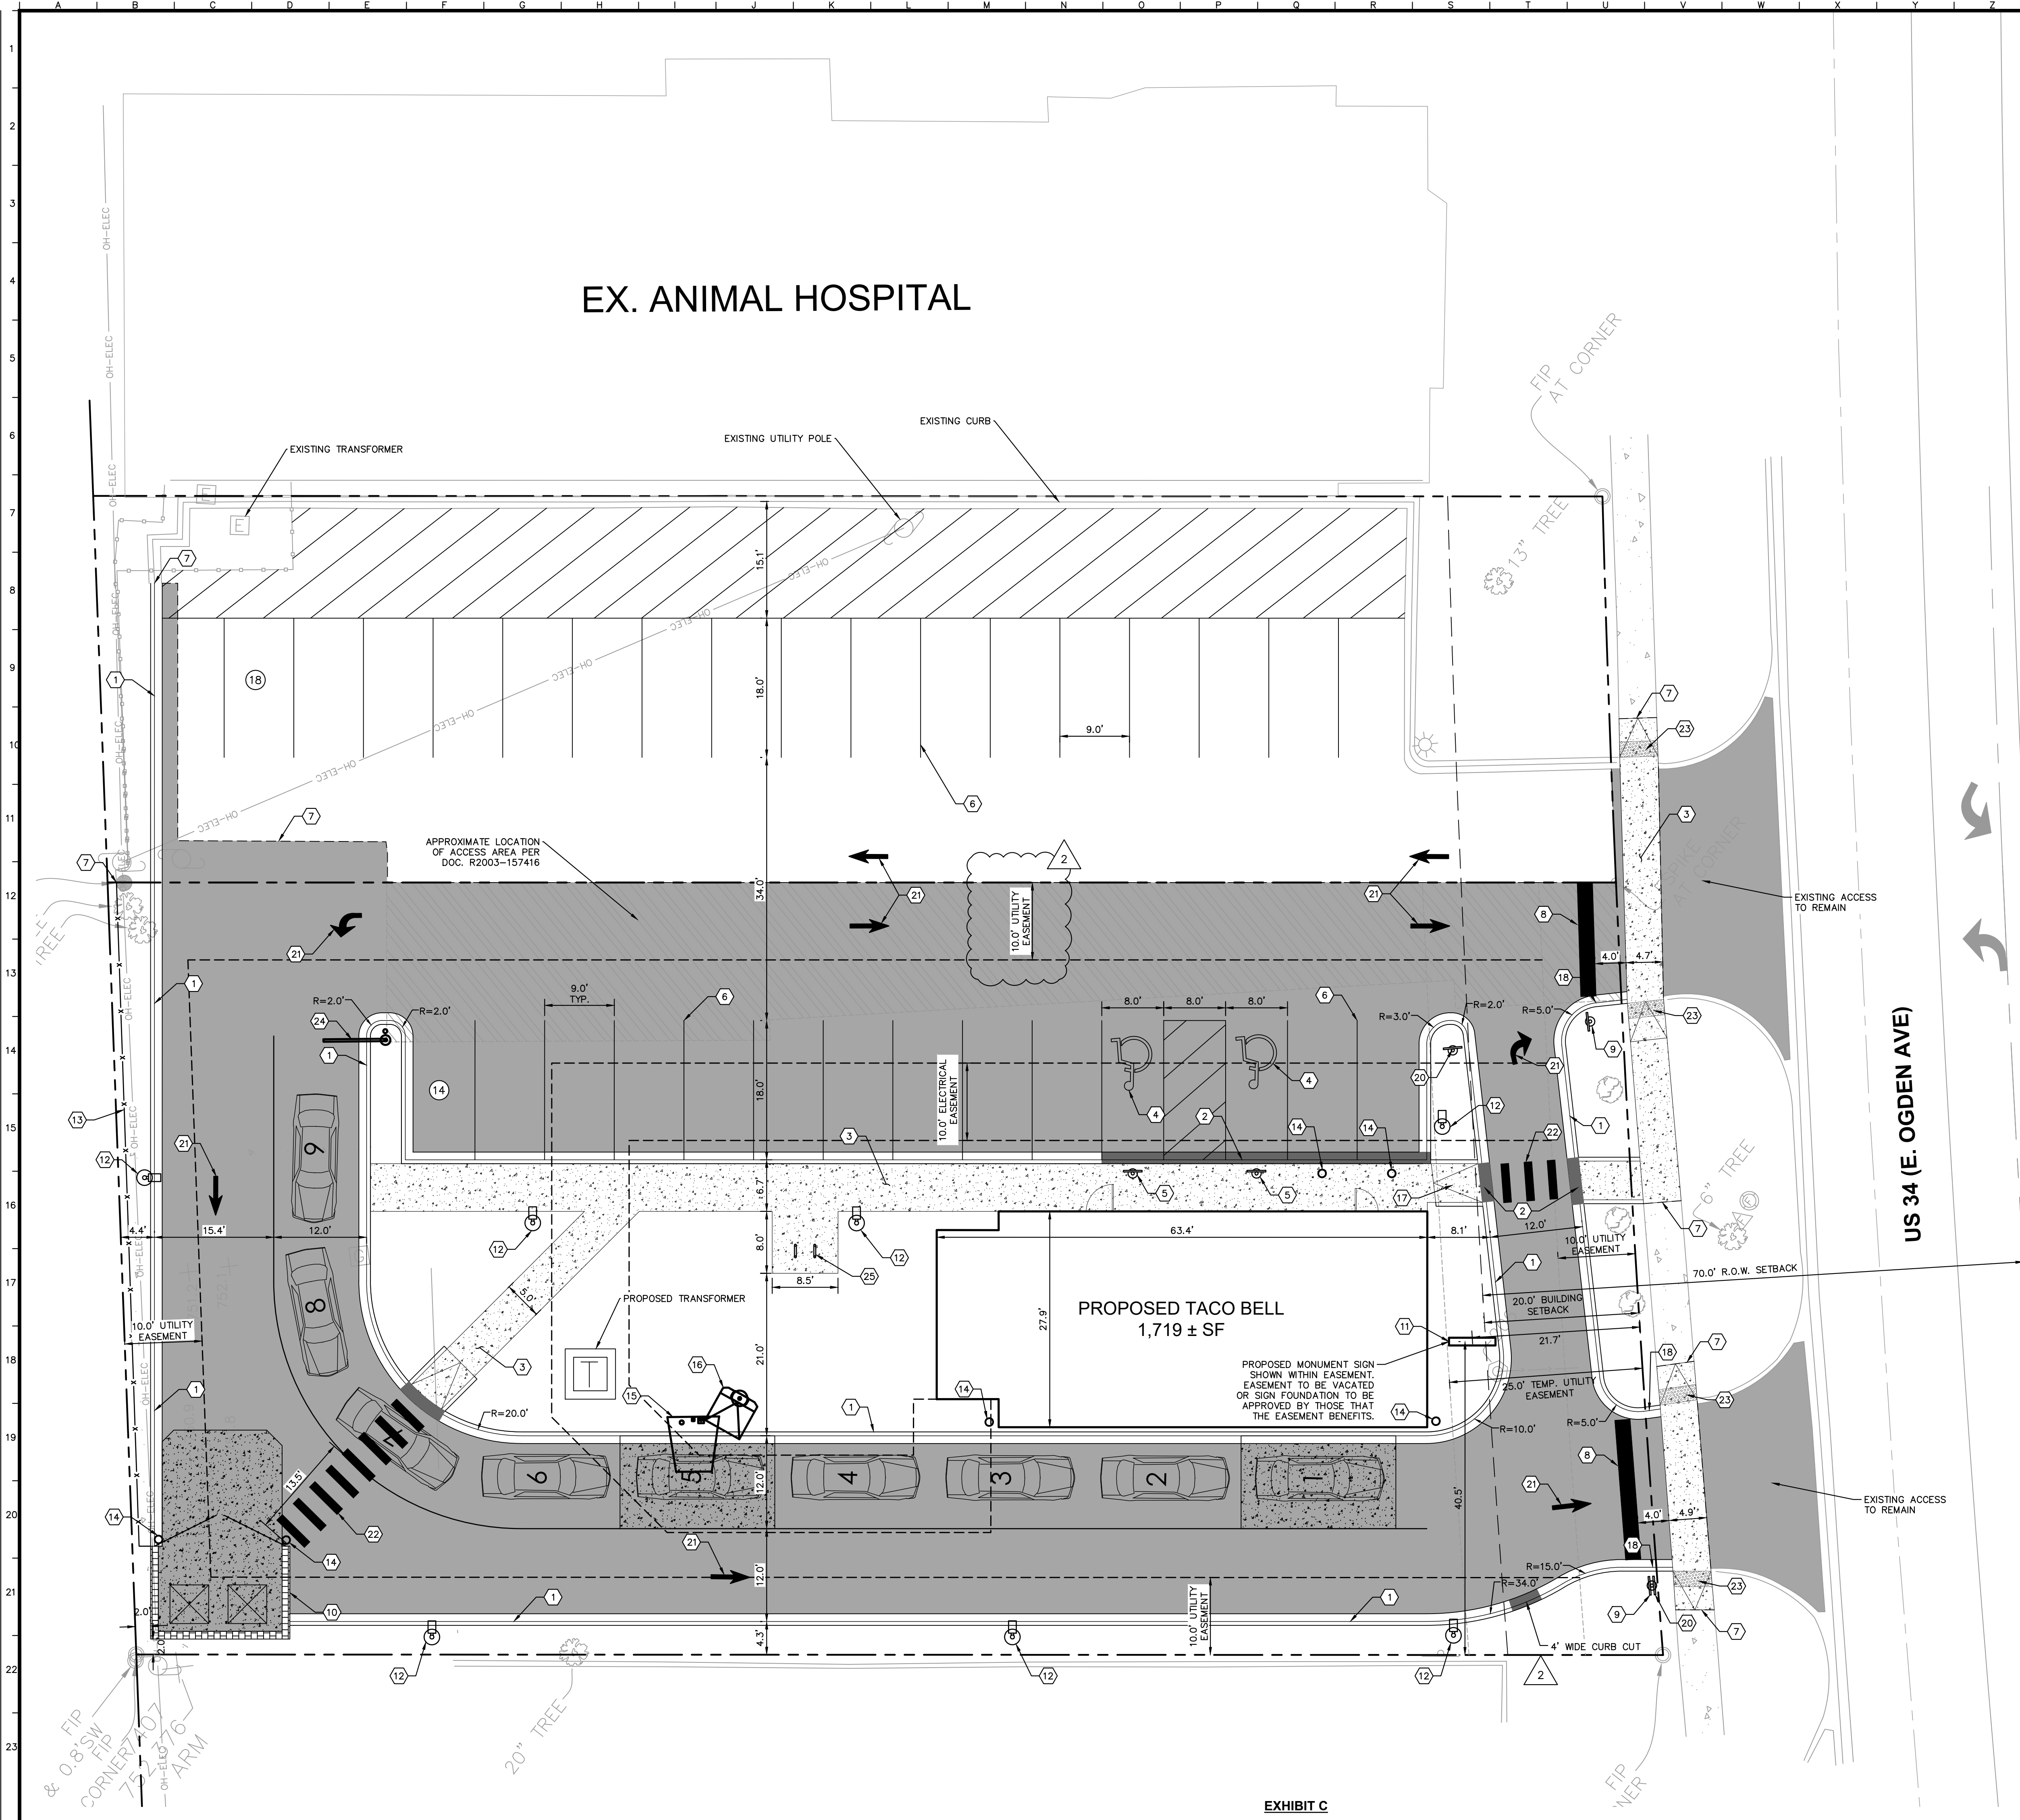

GRAPHIC SCALE IN FEET  
 0 5 10 20

**Call Before You Dig**  
**1-800-892-0123**


- ### GENERAL NOTES
- ALL DIMENSIONS REFER TO THE FACE OF CURB UNLESS OTHERWISE NOTED.
  - BUILDING DIMENSIONS ARE TO THE OUTSIDE FACE OF BUILDING UNLESS OTHERWISE NOTED.
  - REFER TO ARCHITECTURAL AND STRUCTURAL PLANS TO VERIFY ALL BUILDING DIMENSIONS.
  - RADII ADJACENT TO PARKING STALL AND NOT DIMENSIONED ON THIS PLAN SHALL BE 3'-FEET, TYPICAL.
  - REFER TO ARCHITECTURAL PLANS FOR MONUMENT SIGN DETAILS. SEE MEP PLANS FOR SITE ELECTRICAL DRAWINGS.
  - ALL PROPOSED ON-SITE STRIPING SHALL BE PAINTED UNLESS OTHERWISE NOTED.

- ### PAVING AND CURB LEGEND
- HEAVY DUTY ASPHALT PAVEMENT  
SEE CONSTRUCTION DETAILS FOR PAVEMENT SECTION
  - CONCRETE SIDEWALK  
SEE CONSTRUCTION DETAILS FOR PAVEMENT SECTION
  - HEAVY DUTY CONCRETE PAVEMENT  
SEE CONSTRUCTION DETAILS FOR PAVEMENT SECTION
  - STANDARD PITCH CONCRETE CURB AND GUTTER
  - CONCRETE DEPRESSED CURB AND GUTTER

- ### KEY NOTES
- 86.12 CONCRETE CURB AND GUTTER, TYP. (SEE DETAILS, SHEET C7.0)
  - DEPRESSED CONCRETE CURB AND GUTTER
  - CONCRETE SIDEWALK, TYP. (SEE DETAILS, SHEET C7.0)
  - ACCESSIBLE PAVEMENT MARKINGS, TYP. (SEE DETAILS, SHEET C7.0)
  - ACCESSIBLE PARKING SIGN, TYP. (MUTCD R7-8) (SEE DETAILS, SHEET C7.0)
  - 4" WIDE PAINTED SOLID LINE, TYP.
  - CONNECT TO EXISTING PAVEMENT, SIDEWALK, CURB, TYP.
  - 24" WIDE STOP BAR, TYP.
  - STOP SIGN, TYP. (MUTCD R1-1, SEE DETAILS, SHEET C7.0)
  - TRASH ENCLOSURE (SEE ARCHITECTURAL PLANS FOR DETAILS)
  - MONUMENT SIGN (SEE SIGNAGE PLANS FOR DETAILS)
  - LIGHT POLES SHOWN FOR COORDINATION ONLY (SEE SITE LIGHTING PLANS)
  - BOARD ON BOARD FENCE (SEE LANDSCAPE PLAN)
  - BOLLARD, TYP. (SEE DETAILS, SHEET C7.0)
  - SPEAKER POST (SEE ARCHITECTURAL PLANS FOR DETAILS)
  - MENU BOARD (SEE ARCHITECTURAL PLANS FOR DETAILS)
  - ACCESSIBLE RAMP (SEE DETAILS, SHEET C7.0)
  - 3'-FT TRANSITION CURB (SEE DETAILS, SHEET C7.0)
  - BIKE RACK (SEE LANDSCAPE PLAN FOR DETAILS)
  - "DO NOT ENTER" SIGN
  - SITE DIRECTIONAL MARKING (SEE ARCHITECTURAL PLANS FOR DETAILS)
  - 5'-FT WIDE PAINTED CROSSWALK (SEE DETAILS, SHEET C7.0)
  - 2' WIDE TACTICAL WARNING STRIP (SEE DETAILS, SHEET C7.0)
  - CLEARANCE BAR, SEE ARCHITECTURAL PLANS FOR DETAILS
  - BELSON BLACK GLOSSY OBBR-2UR-BK BIKE RACK\*. CONTRACTOR TO INSTALL SURFACE MOUNT PER MNFR. RECOMMENDATIONS \*OR APPROVED EQUAL

NO.	DATE	BY	REVISIONS
1	03/05/24	JPM	CITY COMMENTS
2	01/29/24	JPM	CITY COMMENTS
3	12/15/23	BH	INITIAL CITY SUBMITTAL

**Kimley-Horn**  
 © 2024 KIMLEY-HORN AND ASSOCIATES, INC.  
 111 WEST JACKSON BLVD., SUITE 1300  
 PHONE: 312-728-9445  
 WWW.KIMLEY-HORN.COM

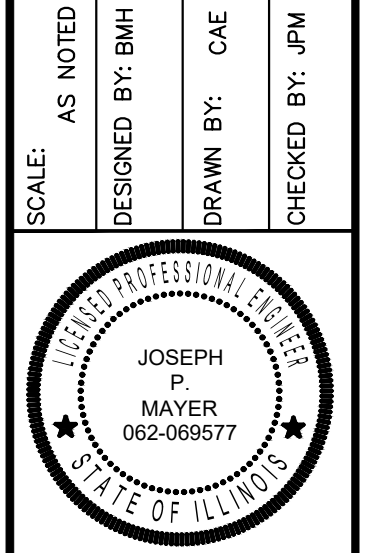

**MRV**  
 ARCHITECTS, INC.

**SITE PLAN**

**TACO BELL**  
 1019 E. OGDEN AVE.  
 NAPERVILLE, IL

ORIGINAL ISSUE:  
 12/15/2023  
 KHA PROJECT NO.  
 268581000  
 SHEET NUMBER  
**C3.0**